



© COPYRIGHT 2008 CLARK ENGINEERING & SURVEYING, P.C.
 ALL RIGHTS RESERVED AND "UNAUTHORIZED DUPLICATION
 IS A VIOLATION OF APPLICABLE LAWS."
 UNAUTHORIZED ALTERATIONS TO THIS DOCUMENT IS A VIOLATION OF
 SECTION 7209 SUBDIVISION 2 OF THE NEW YORK STATE EDUCATION LAW
 © 2010 Project: 2010601-Dwg\2010601-C100.dwg
 May 04, 2007

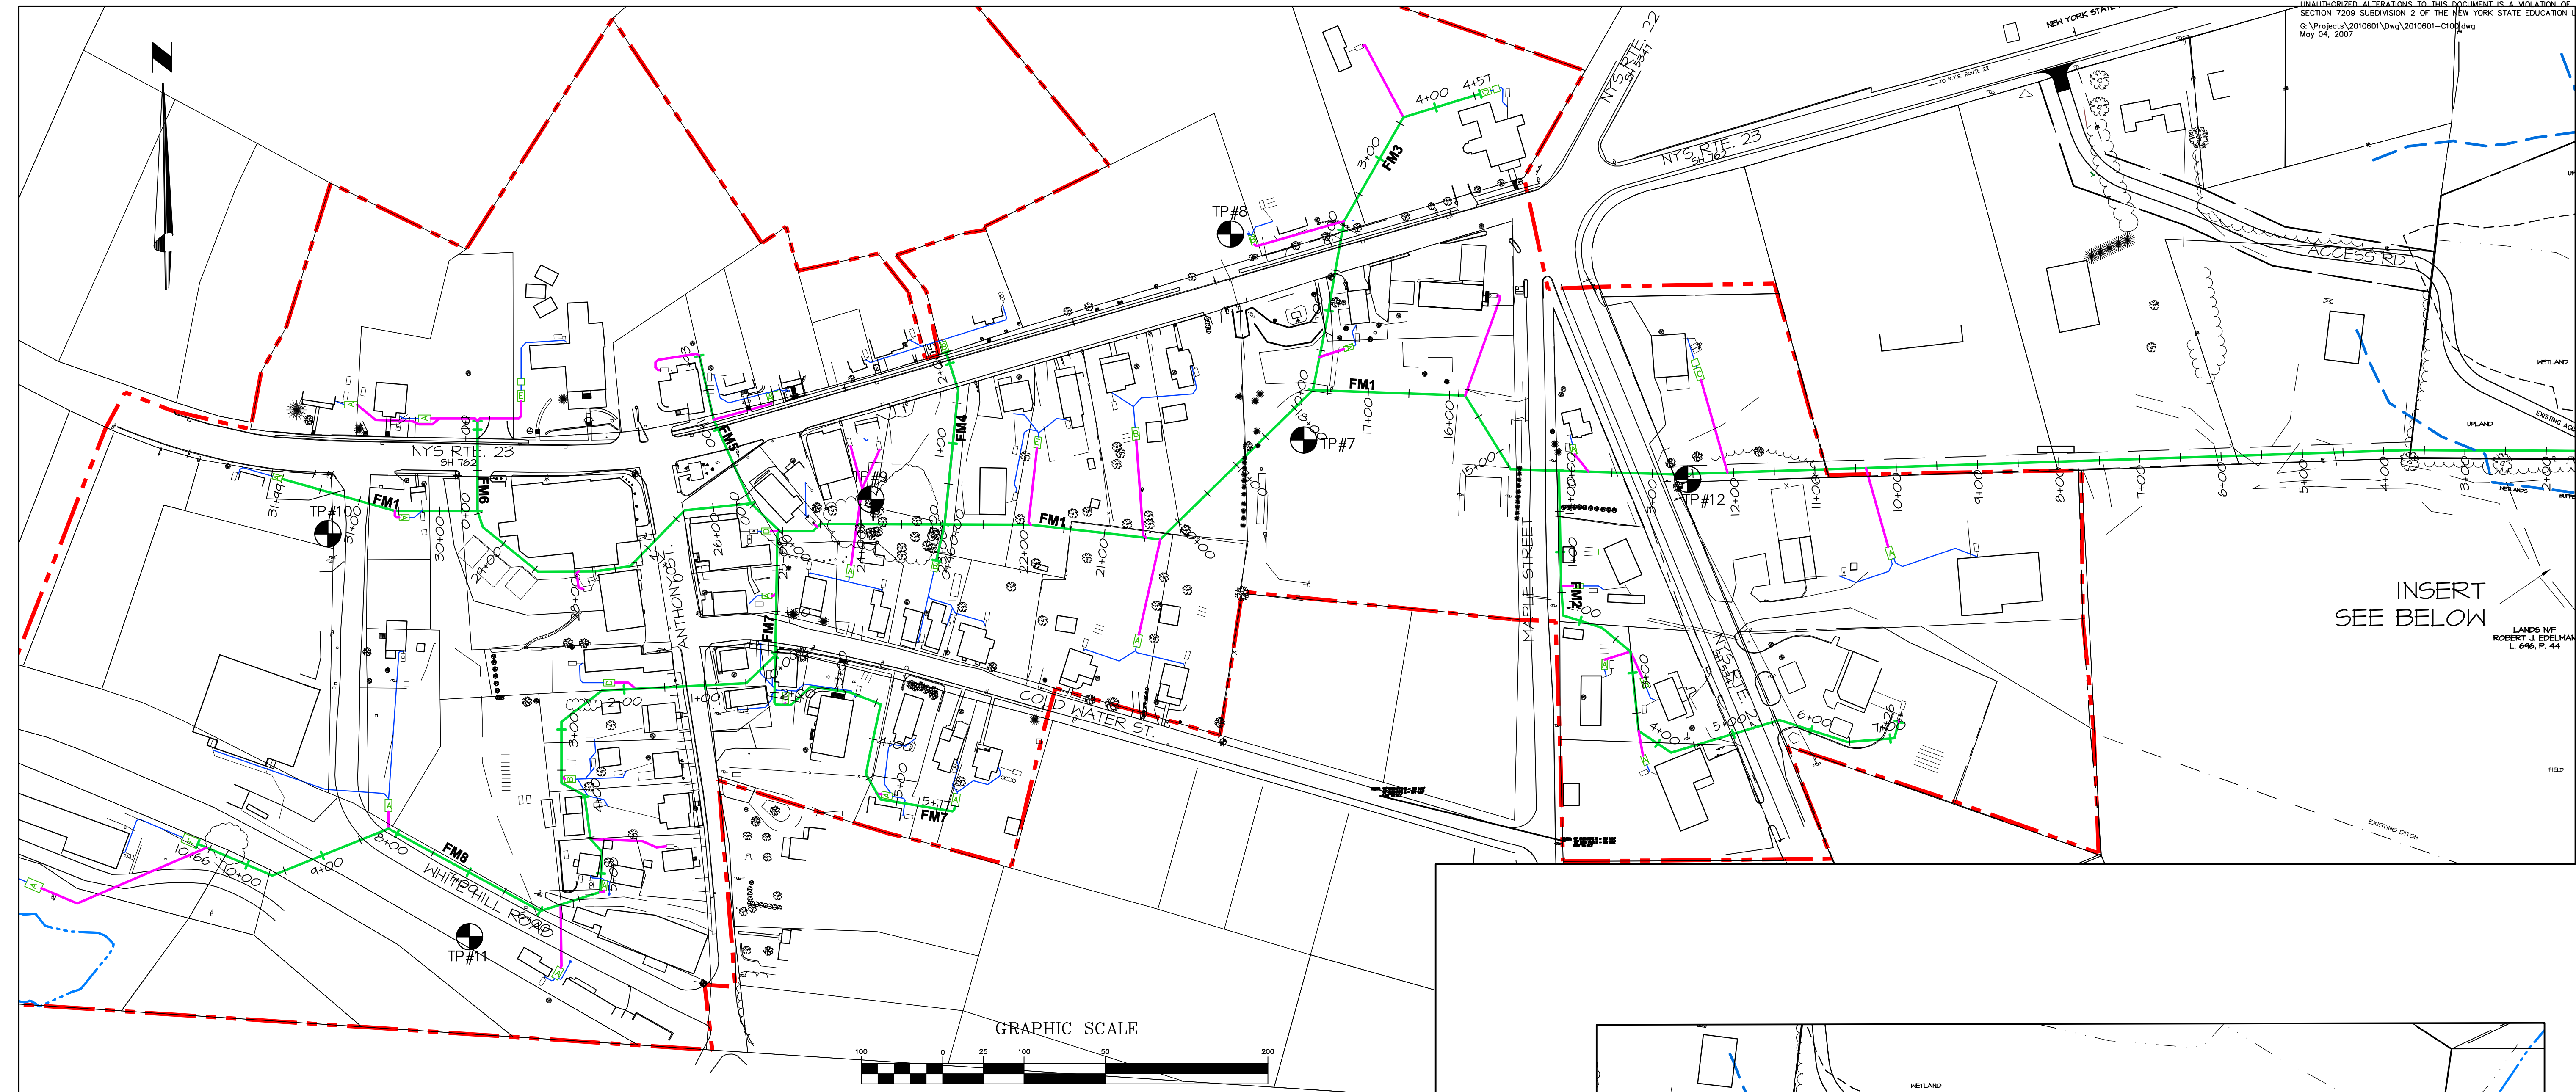

INSERT
 SEE BELOW

1 PLAN
 REF: SCALE: 1" = 100'

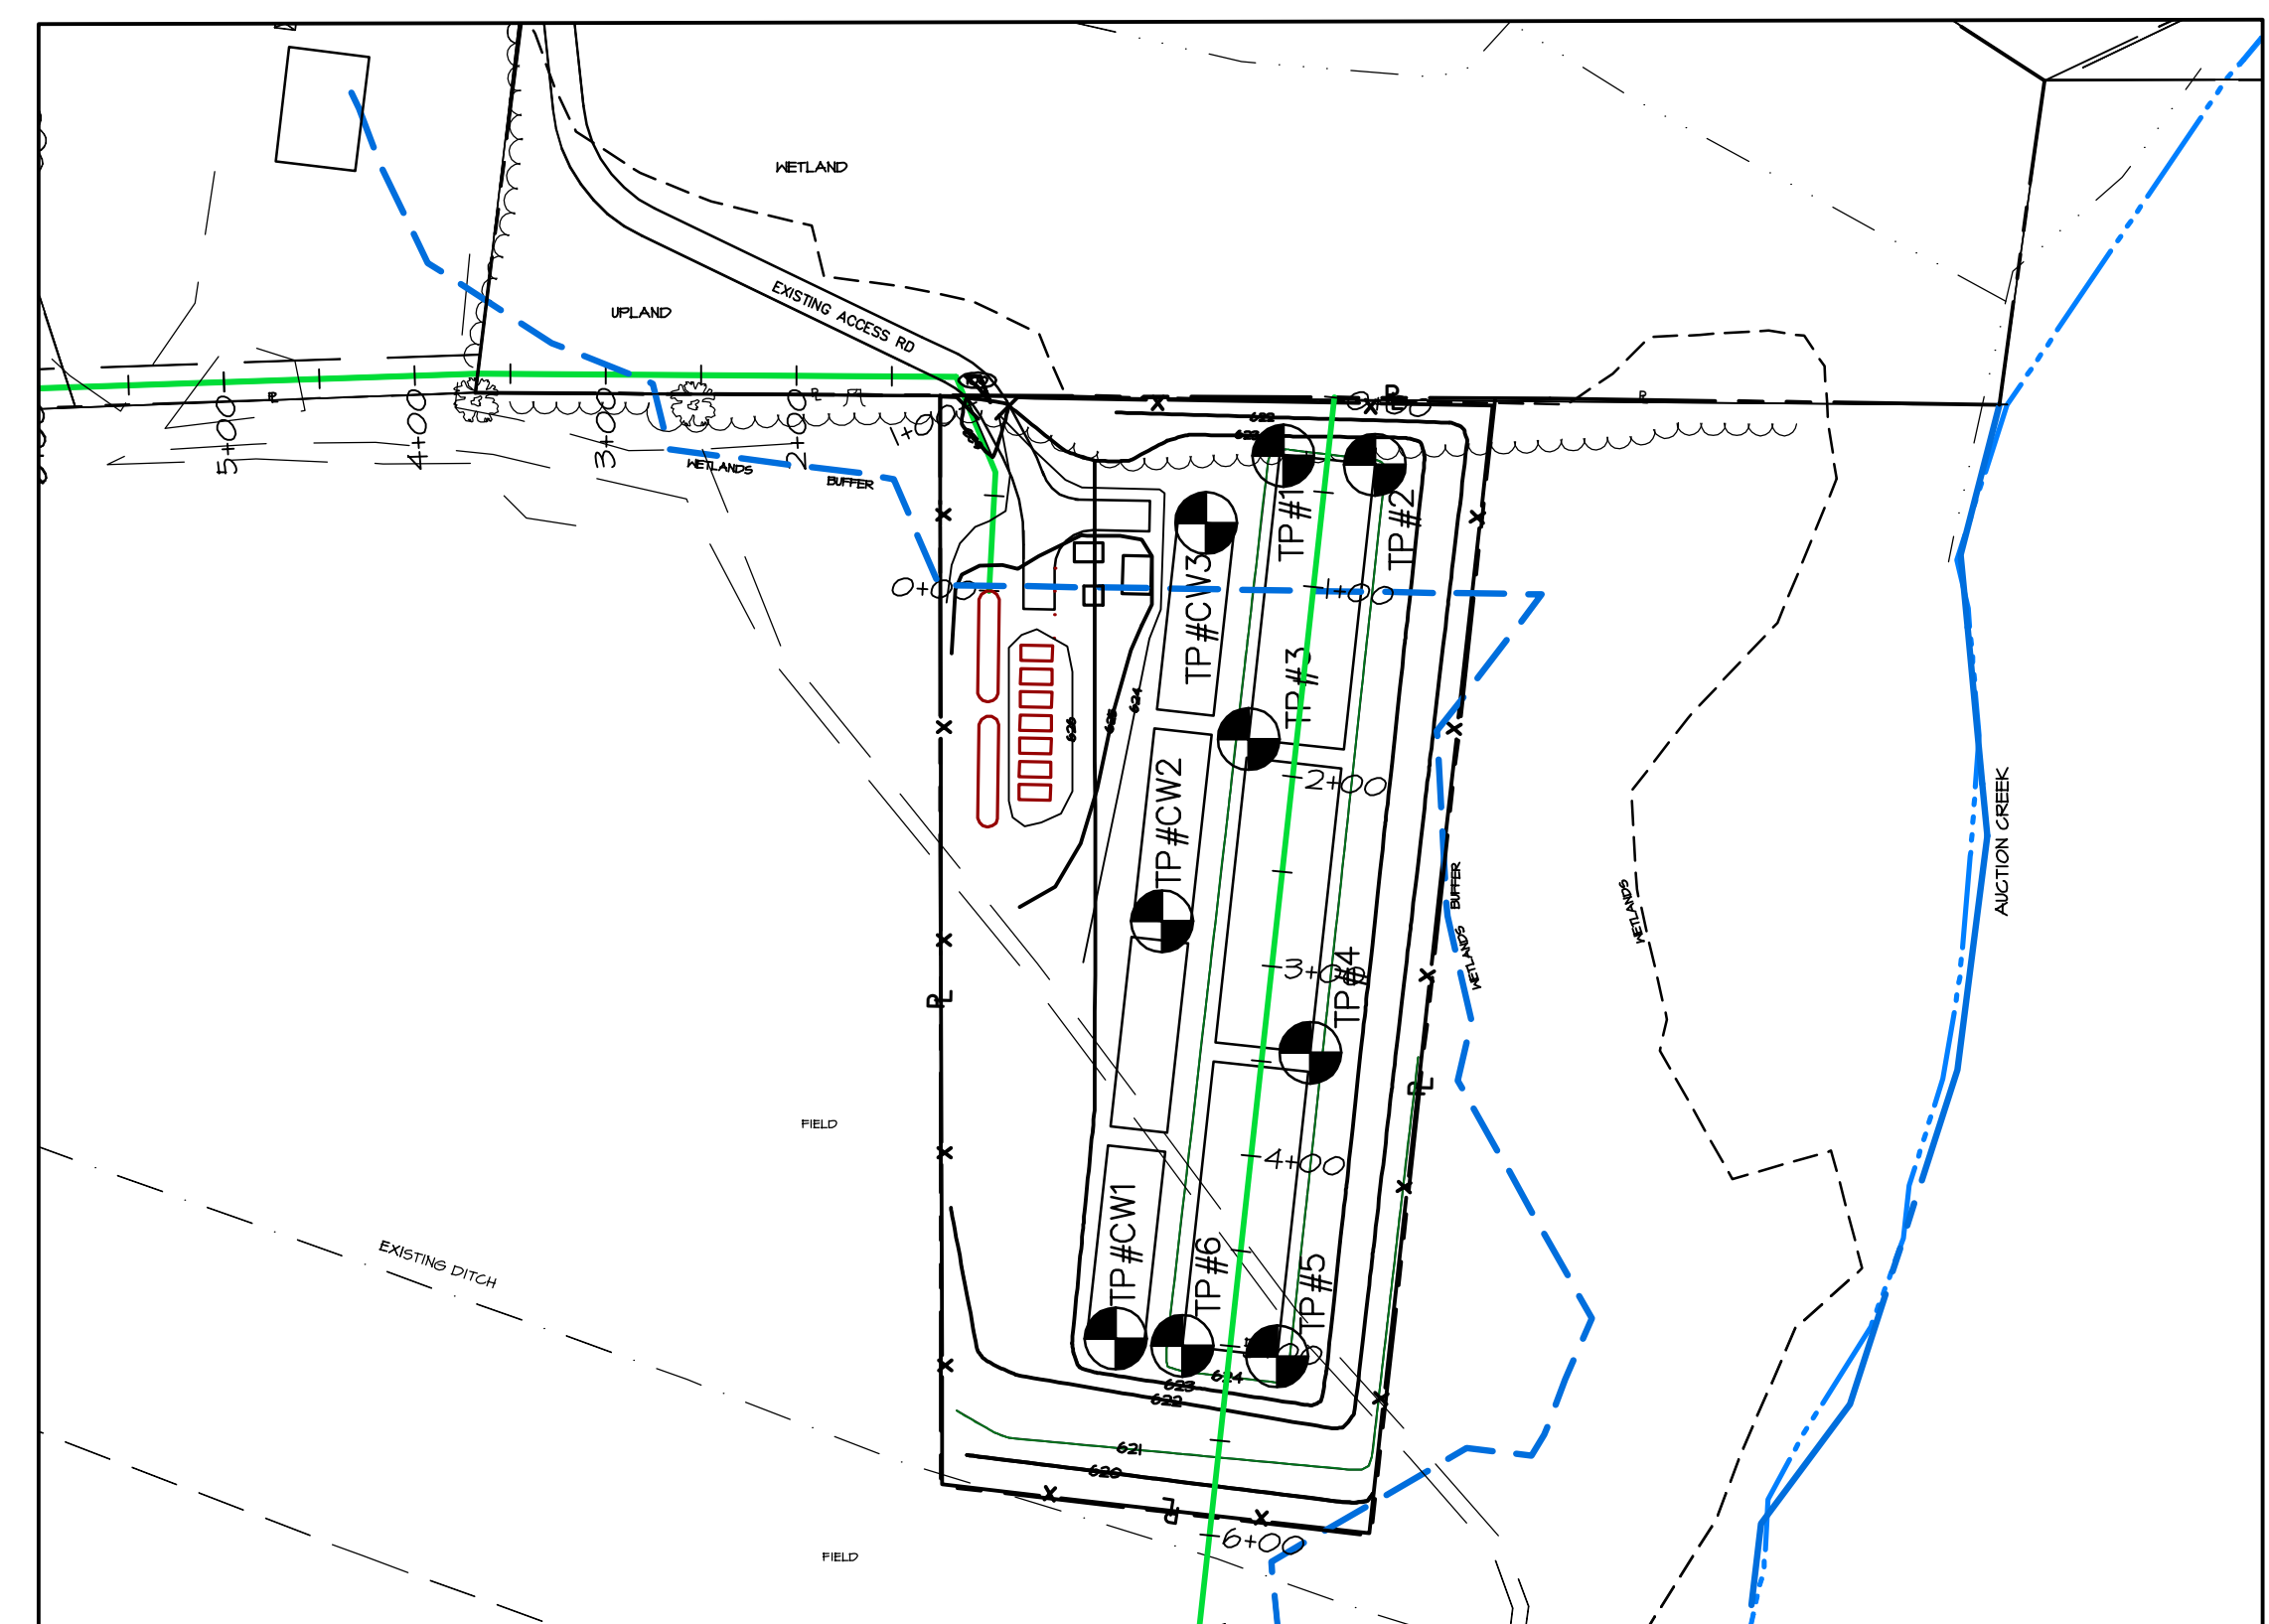

2 INSERT - TREATMENT SITE PLAN
 REF: SCALE: 1" = 100'

CLARK
 ENGINEERING &
 SURVEYING, P.C.
 20 SHAKER RD., BOX 730, NEW LEANDON, NY 12125
 TEL: (518) 794-8613 FAX: (518) 766-5663
 www.clarkpec.com

TOWN OF HILLSDALE
 WASTEWATER COLLECTION
 & TREATMENT SYSTEM
 COLUMBIA COUNTY, NEW YORK

NO.	DATE	BY	REVISIONS:
1	11/2/2008	ERK	SUBMISSION FOR DEC APPROVAL
2		ERK	APPENDIX 2 - PONDHOUSE VISIBILITY

PROJECT NO.
2010601
 DRAWING NAME
2010601-C100
 DRAWING NO.
C100

OVERALL SITE PLAN